




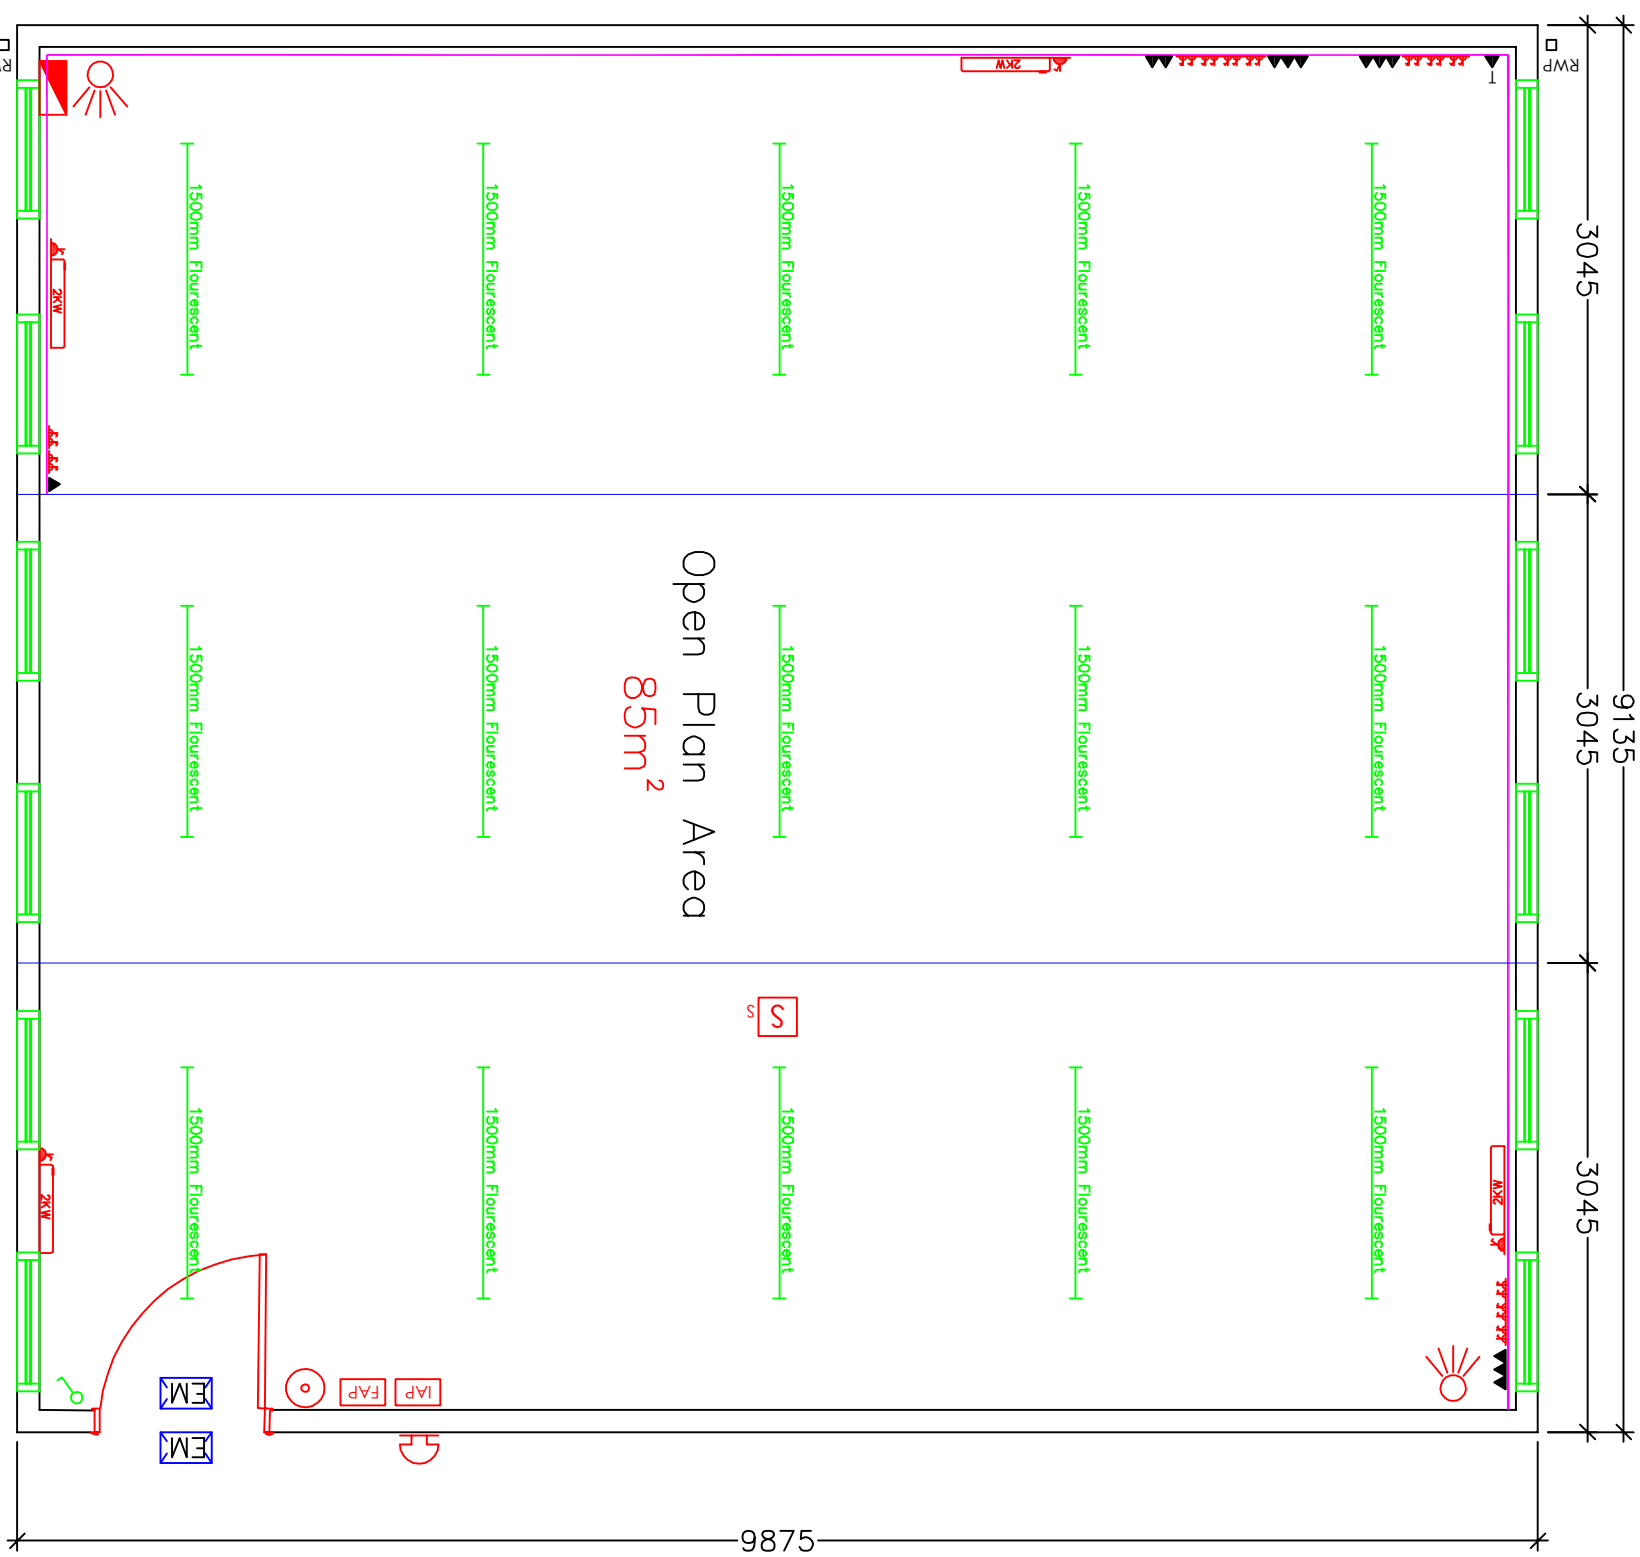


NOTES



Electrical Legend

-  Mains Distribution Board
-  1500mm HF Fluorescent Light with Diffuser
-  2 kW Convector Heater
-  Light Switch
-  Low Level Switched Socket Outlet
-  Emergency Light

Open Plan Area
85m²

By	MJM	Date	-/-/-	Re	1
Client					
Project	3 Bay				
Title	Single Classroom				
	Plan Layout				
Drawn:	MJC	Date:	28/09/2016		
Scale:	1:75	Drawing Size:	A3		

